


REVISIONS		
No./Date	Description	By

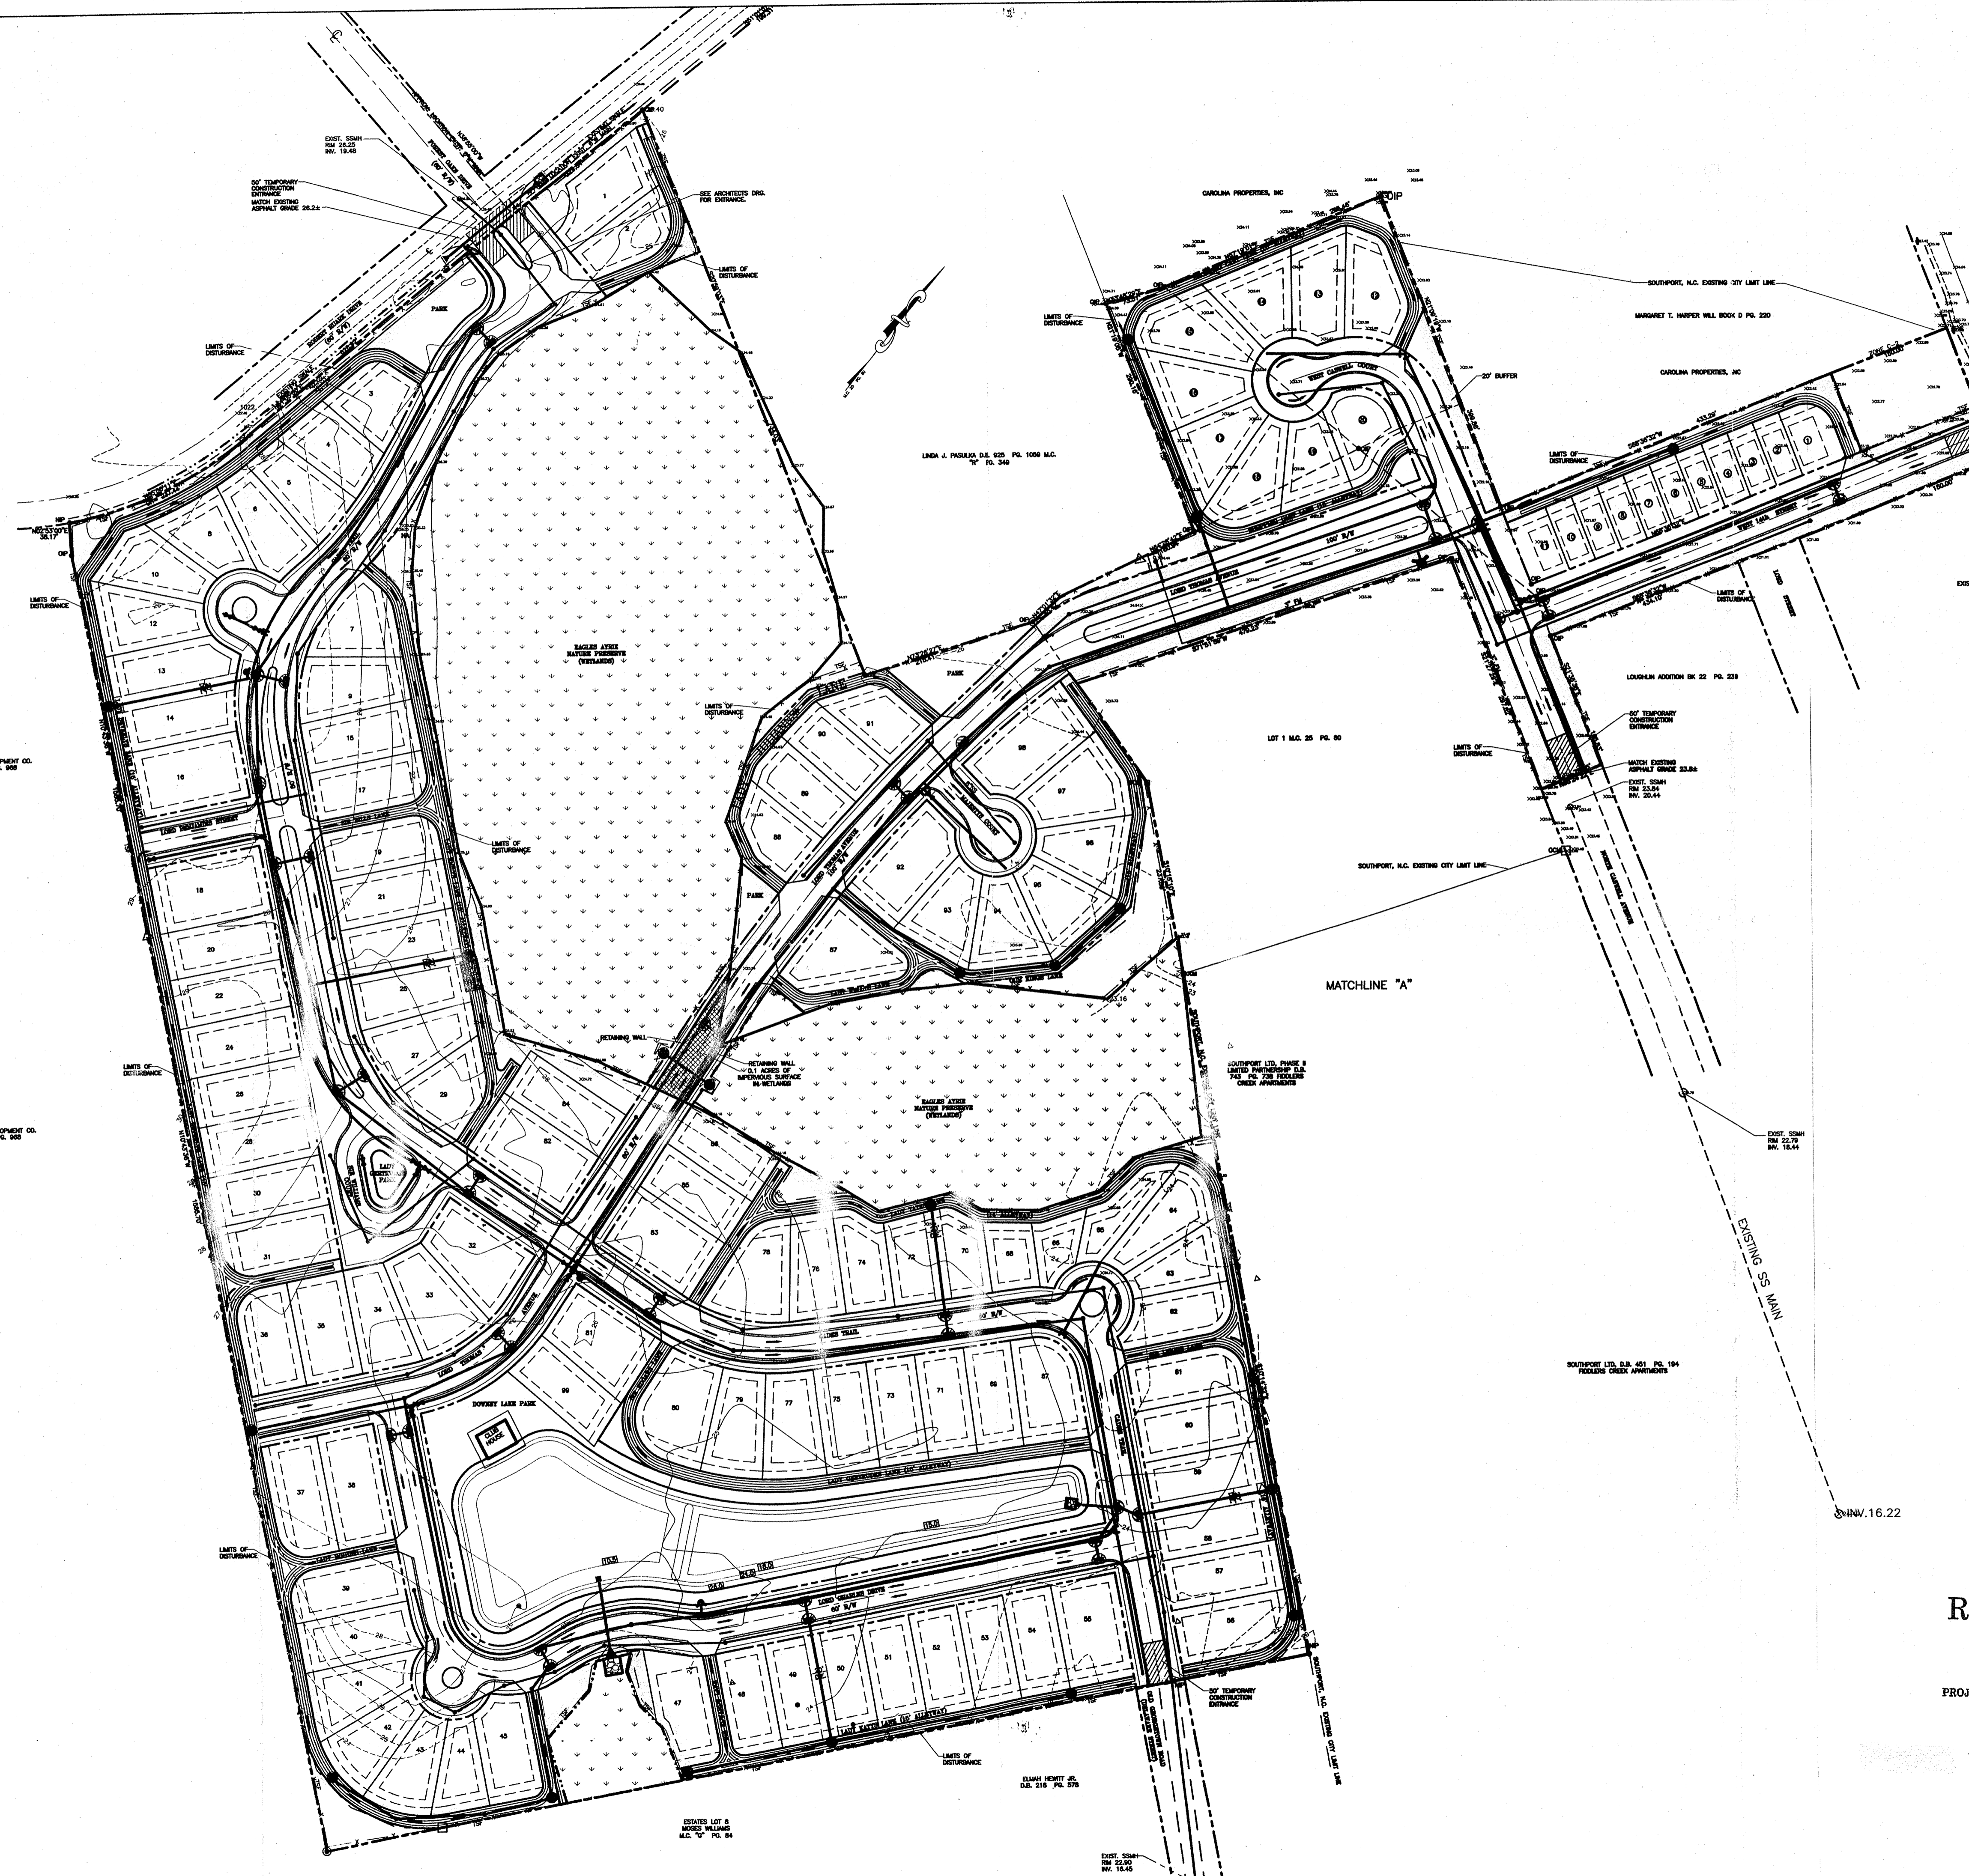

**SITE PLAN**  
1" = 100'

**RECEIVED**

OCT 26 2004

DWG  
PROJ # Sw2041011

DRAINAGE AREA TO POND

**TRIPP ENGINEERING, P.C.**  
419 Chestnut Street  
Wilmington, North Carolina 28401  
Phone 910-763-5100  
Fax 910-763-5631  
© 2004 TRIPP ENGINEERING, P.C.



DATE 10-26-04  
DESIGN PGT  
DRAWN JLR

**CO**  
SHEET 1 OF 1  
04091